

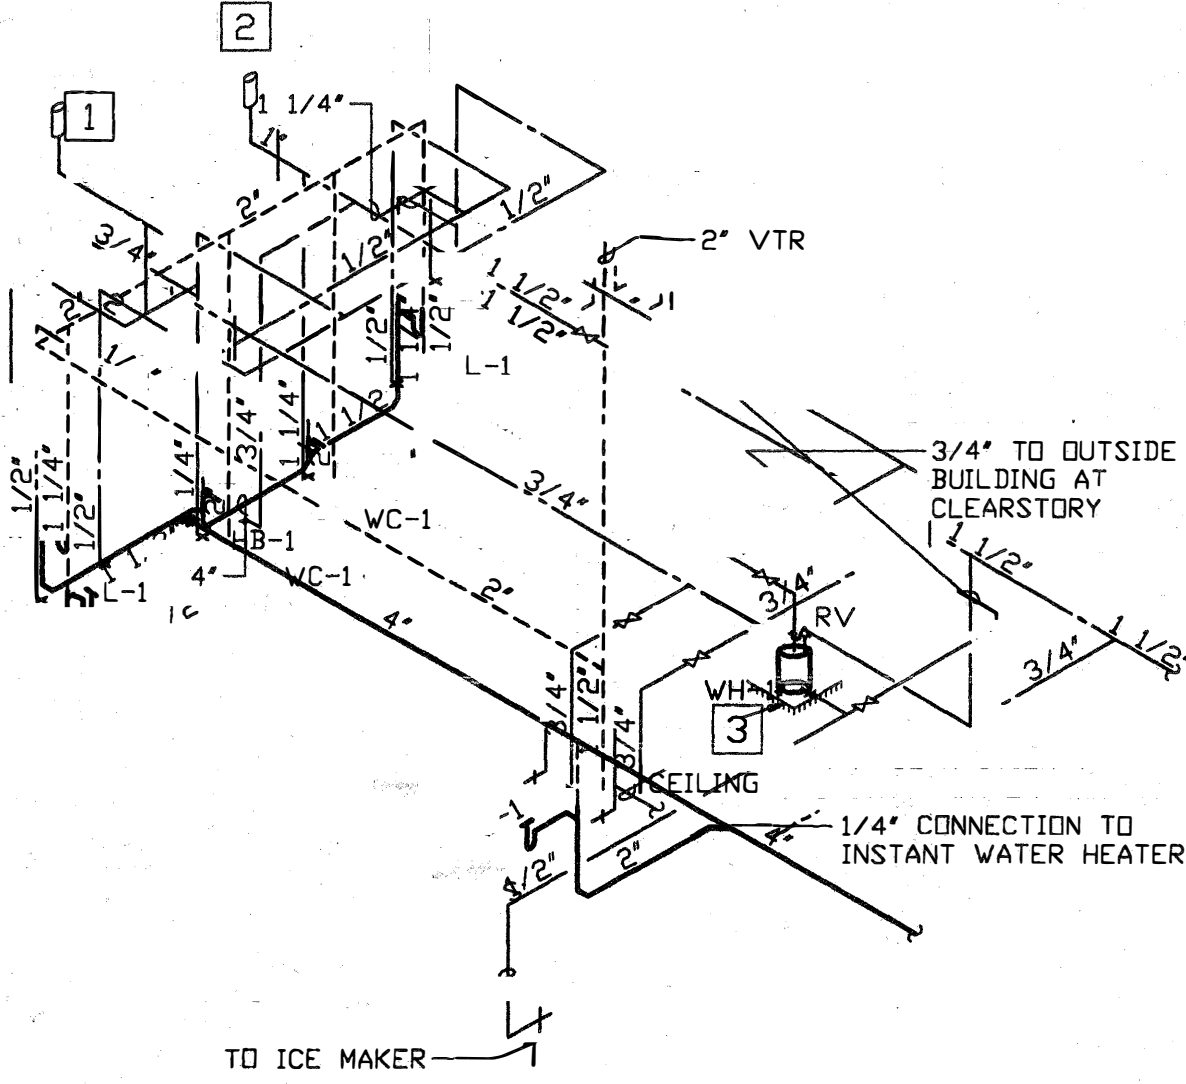


PLUMBING ROUGH-IN SCHEDULE									
NO.	FIXTURE	SERVICE SIZE (IN.)		REMARKS					
		WASTE	VENT						
DF-1	DRINKING FOUNTAIN	1 1/2"	1 1/4"	1/2"	COOLER/BARRIER FREE				
L-1	LAVATORY	1 1/2"	1 1/4"	1/2"	COUNTER MOUNTED				
L-2	LAVATORY	1 1/2"	1 1/4"	1/2"	COUNTER MOUNTED				
WC-1	WATER CLOSET	4"	2"	---	WALL MOUNTED				
WC-2	WATER CLOSET	4"	2"	---	WALL MOUNTED/BARRIER FREE				
WC-3	WATER CLOSET	4"	2"	---	FLOOR MOUNTED				
S-1	SINK	2"	1 1/2"	1/2"	X				
S-2	SINK	2"	1 1/2"	1/2"	X				
S-3	SINK	2"	1 1/2"	1/2"	X				
S-4	SINK	2"	1 1/2"	1/2"	X				
S-5	SINK	3"	1 1/2"	3/4"	JANITOR SINK				


- SHEET NOTES (M-2)
- J.R. SMITH HYDRASORB WATER HAMMER ARRESTOR, FIGURE NO. 5005(3/4")
 - J.R. SMITH HYDRASORB WATER HAMMER ARRESTOR, FIGURE NO. 5010(1")
 - PROVIDE A 24"X24"X2" WATERPROOF DRIP PAN FOR THE WATER HEATER TO SET IN.
 - VENT P & T RELIEF VALVE THRU CLEARSTORY.

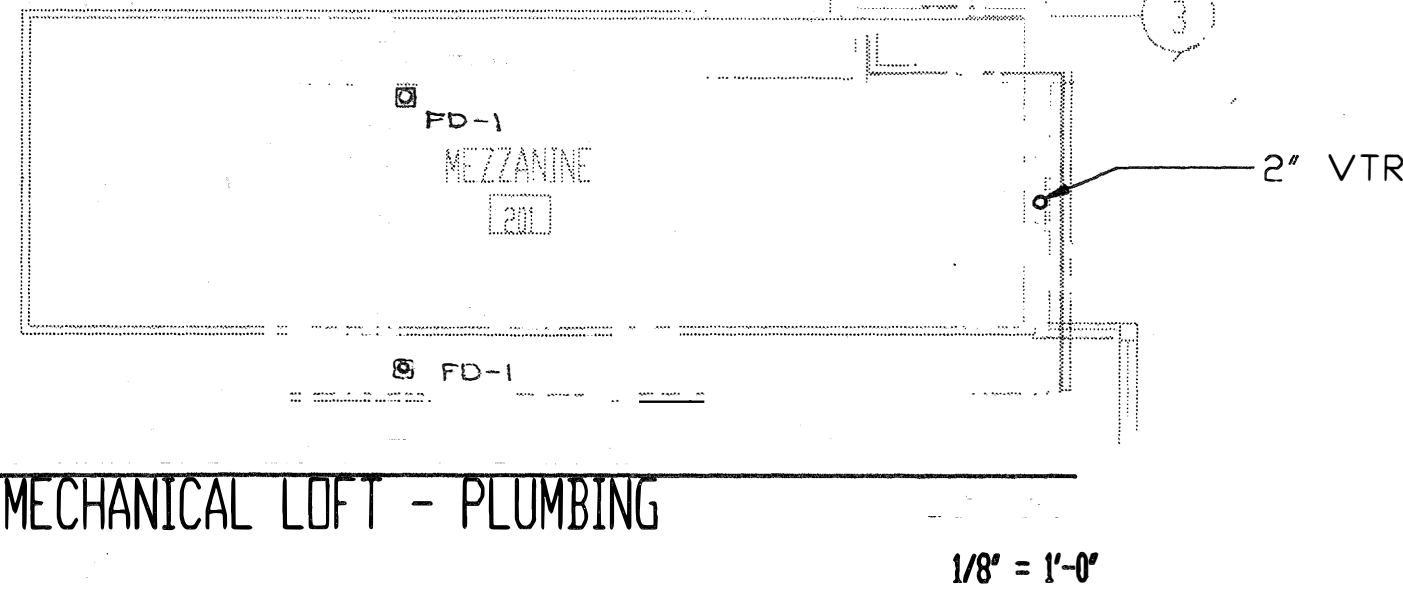


1 PLUMBING RISER
M-2 SCALE: NONE

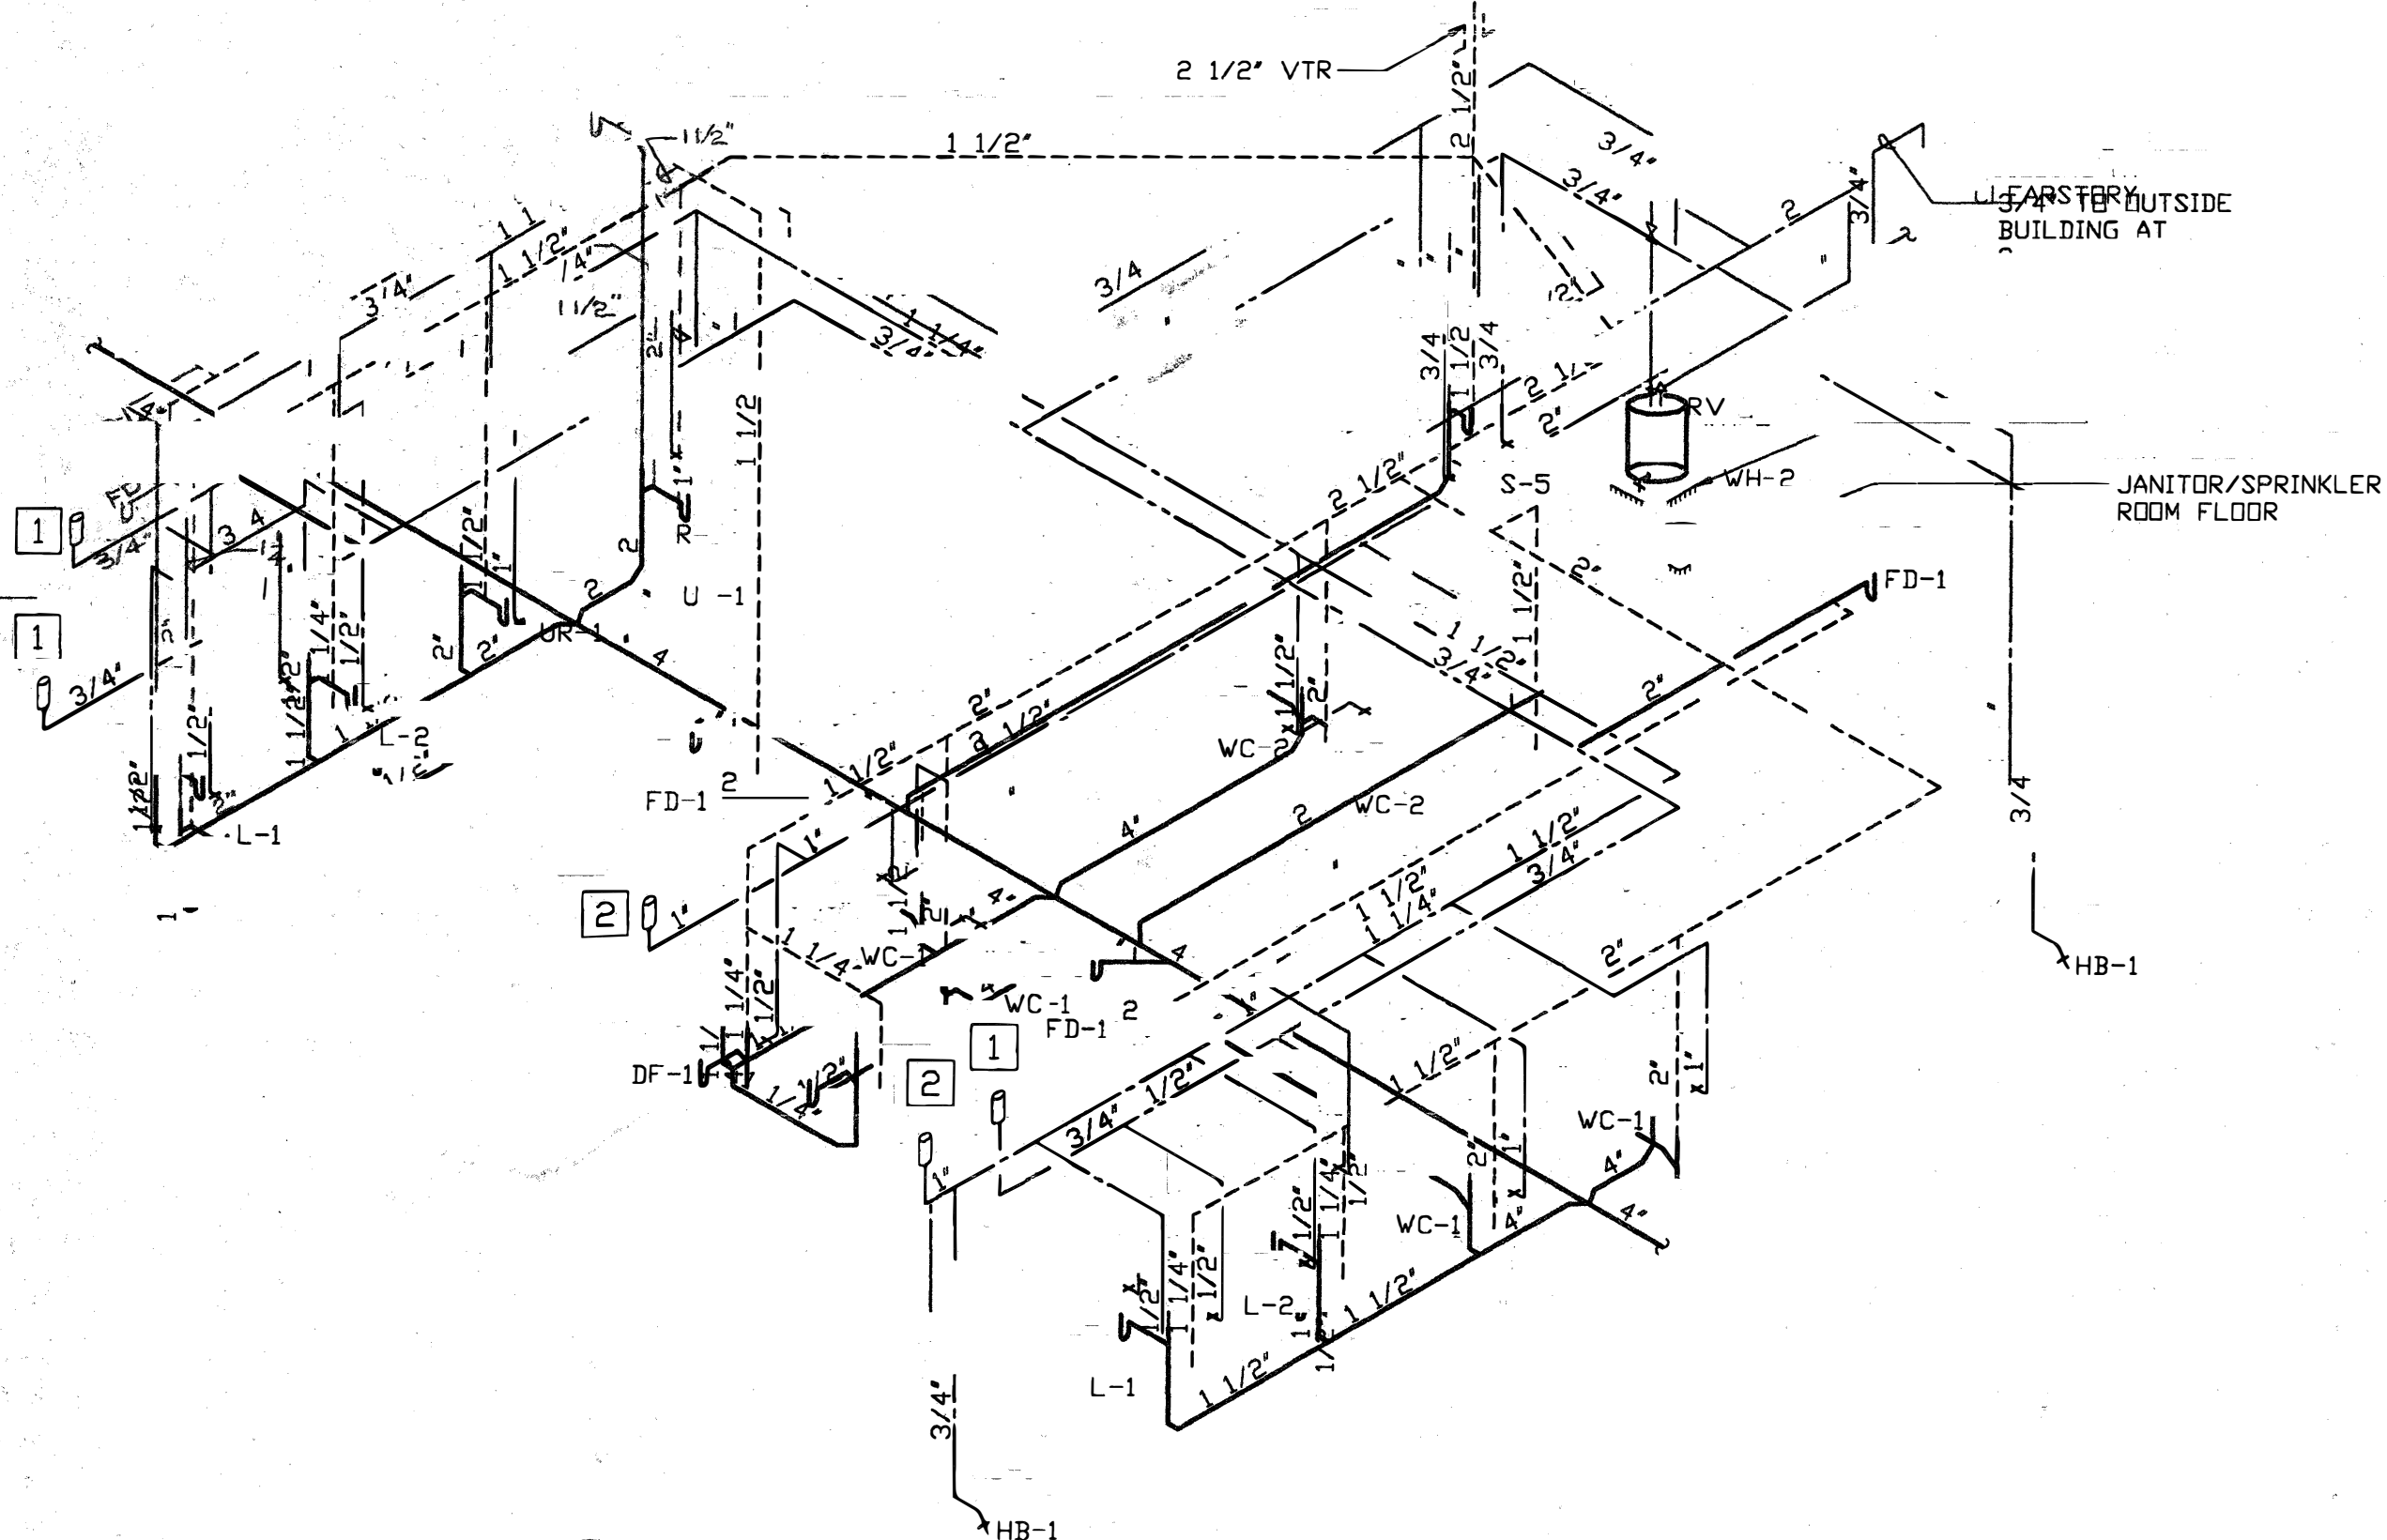

2 PLUMBING RISER
M-2 SCALE: NONE

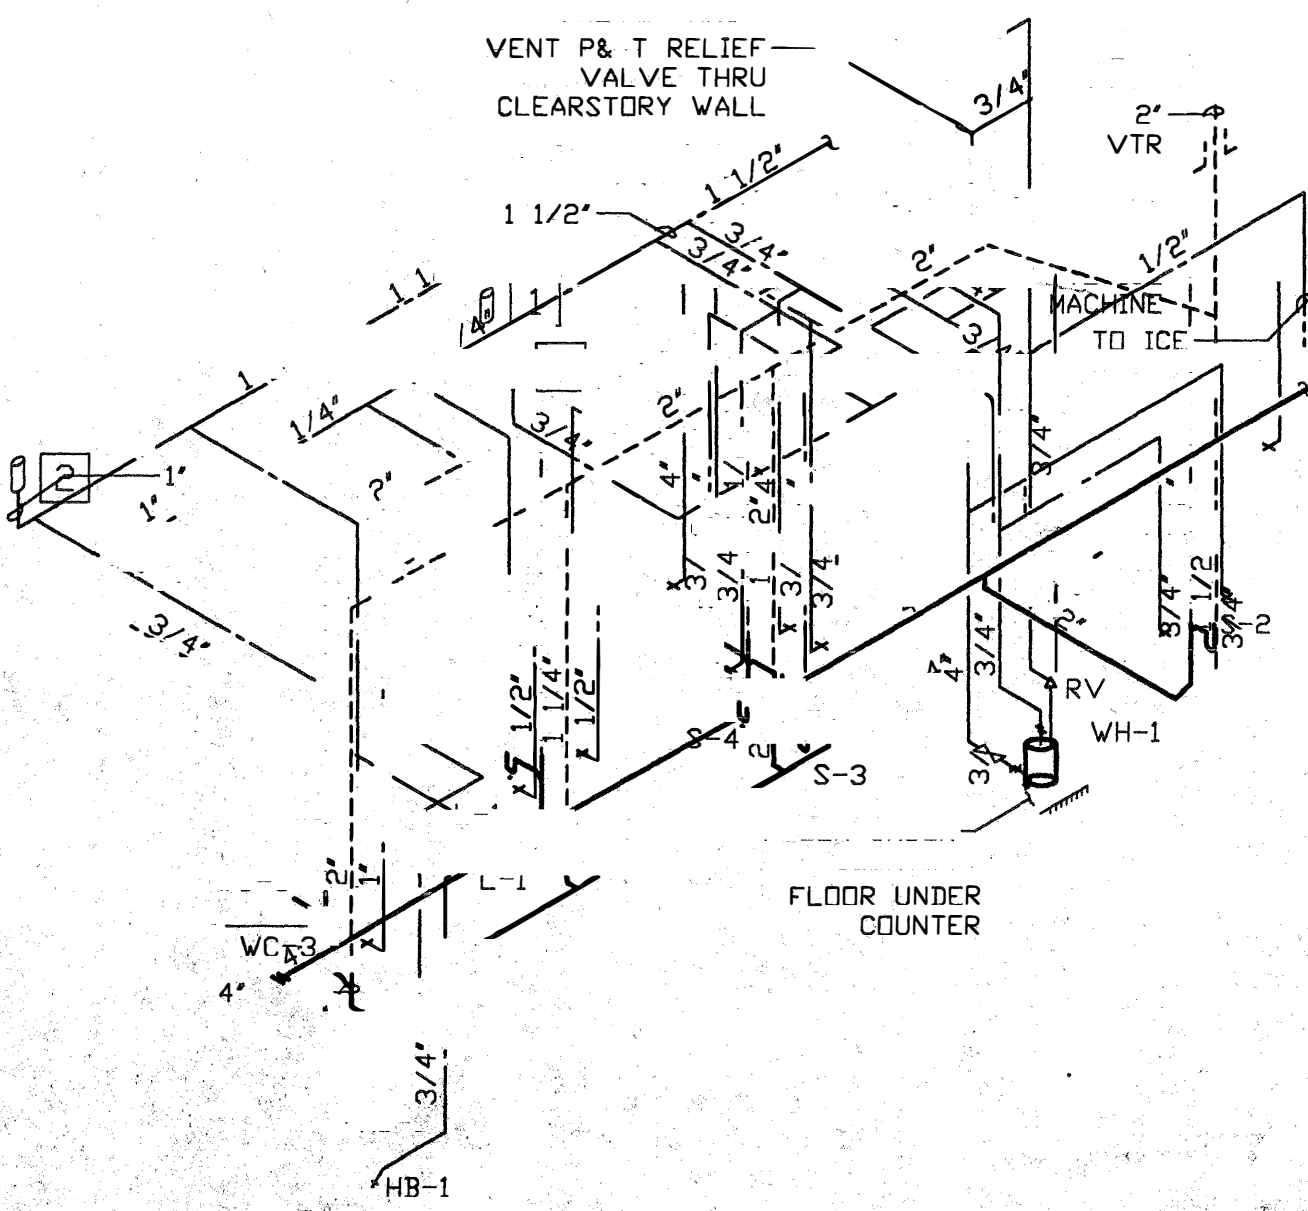


3 PLUMBING RISER
M-2 SCALE: NONE

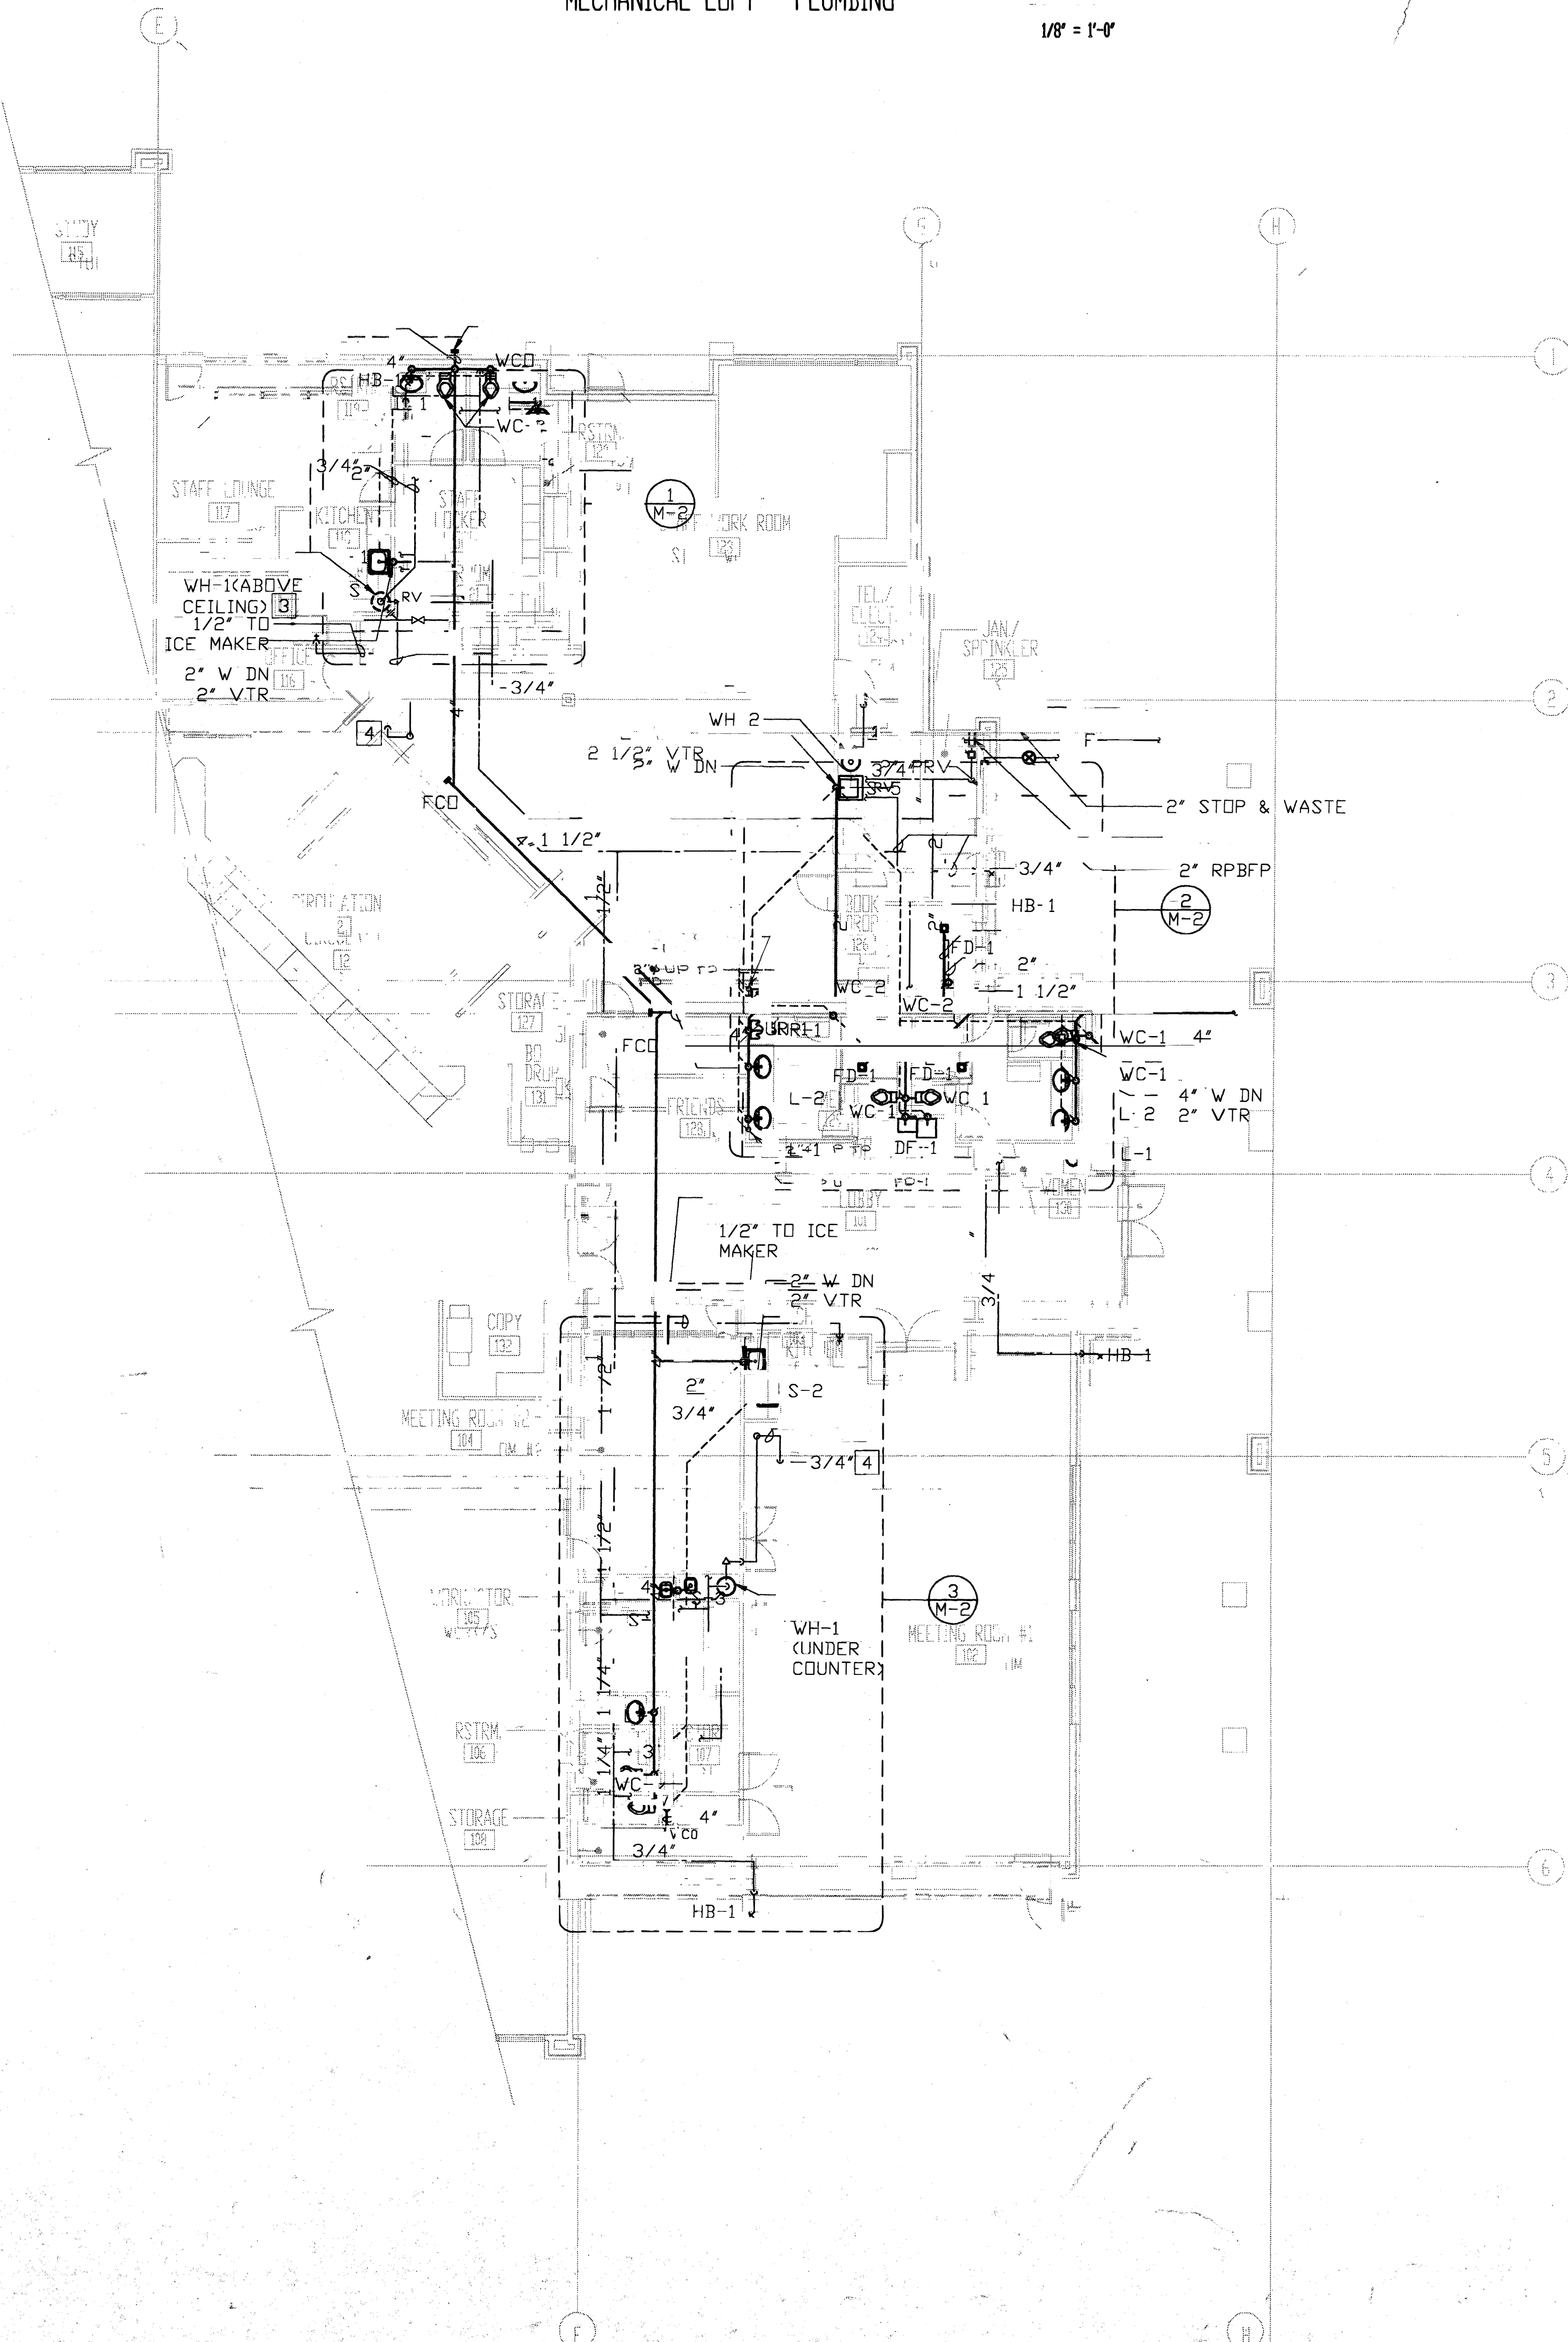


MAIN FLOOR PLAN (PARTIAL) - PLUMBING

THE LEWIS ARCHITECTS
800 Northrup Way
Suite 100
Fremont, WA 98004
Phone (206) 822-5602
Fax (206) 822-5490


Issue By: _____
Checked: _____
Approved: _____

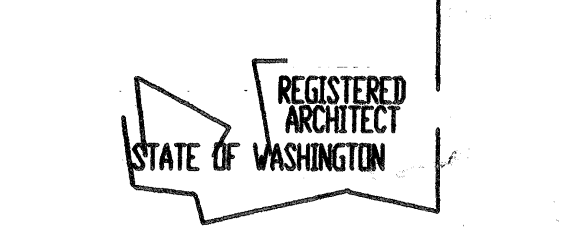

SPURGEON & ASSOCIATES, INC.
CONSULTING ENGINEERS
15 SOUTH GRADY WAY, SUITE 628
RENTON, WASHINGTON, 98055
FAX 206-235-5191
PHONE 206-235-5190

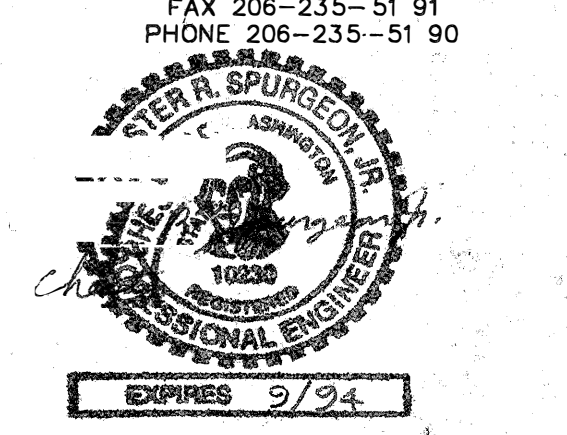

Issue	Description	Date
-------	-------------	------

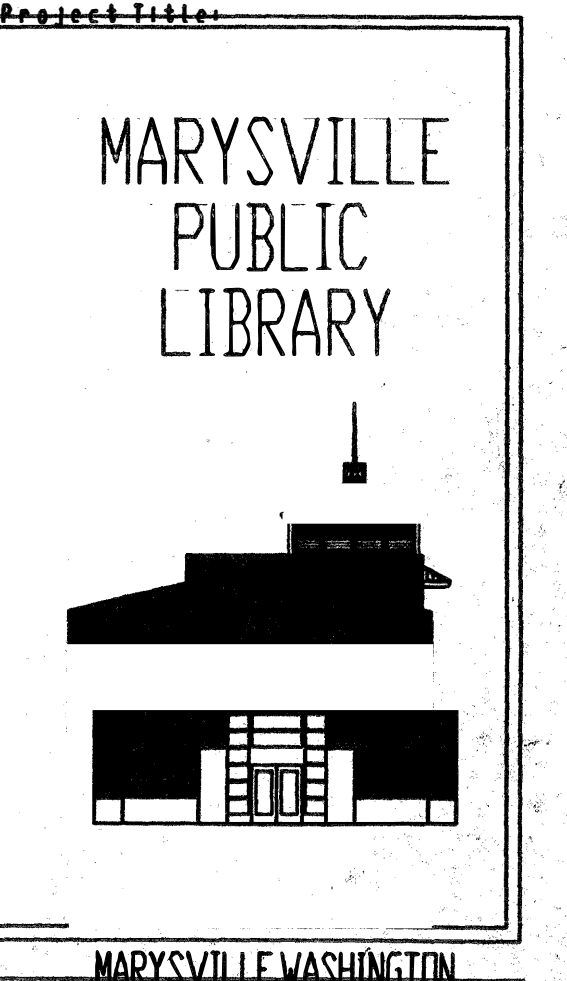

Sheet Title: PLUMBING FLOOR PLAN

Scale: AS SHOWN
Project No: 2002
Date: 8/28/94

Sheet No: M-2