
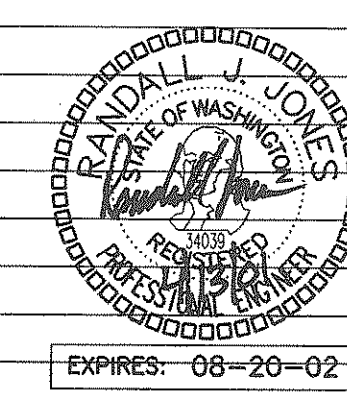
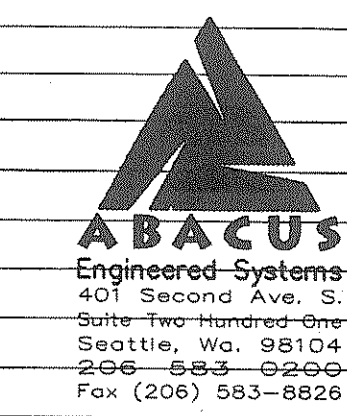


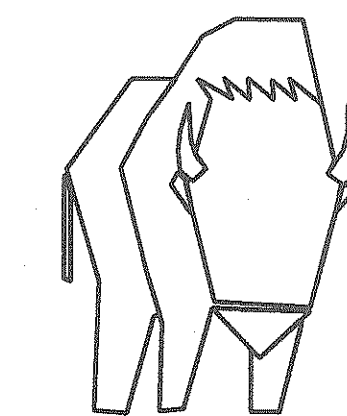

buffalodesign
architecture & interiors
1501 western
suite 500
seattle, wa
98101
206 467 6306
fax 206 624 1494

Sno-Isle
Regional Library System


monroe library
village way,
monroe, washington 98272

BID
SET




project: 00-002
contents:
mechanical roof plan

drawn: fem
checked: rj
date: 4/17/01
revised:

m2.2

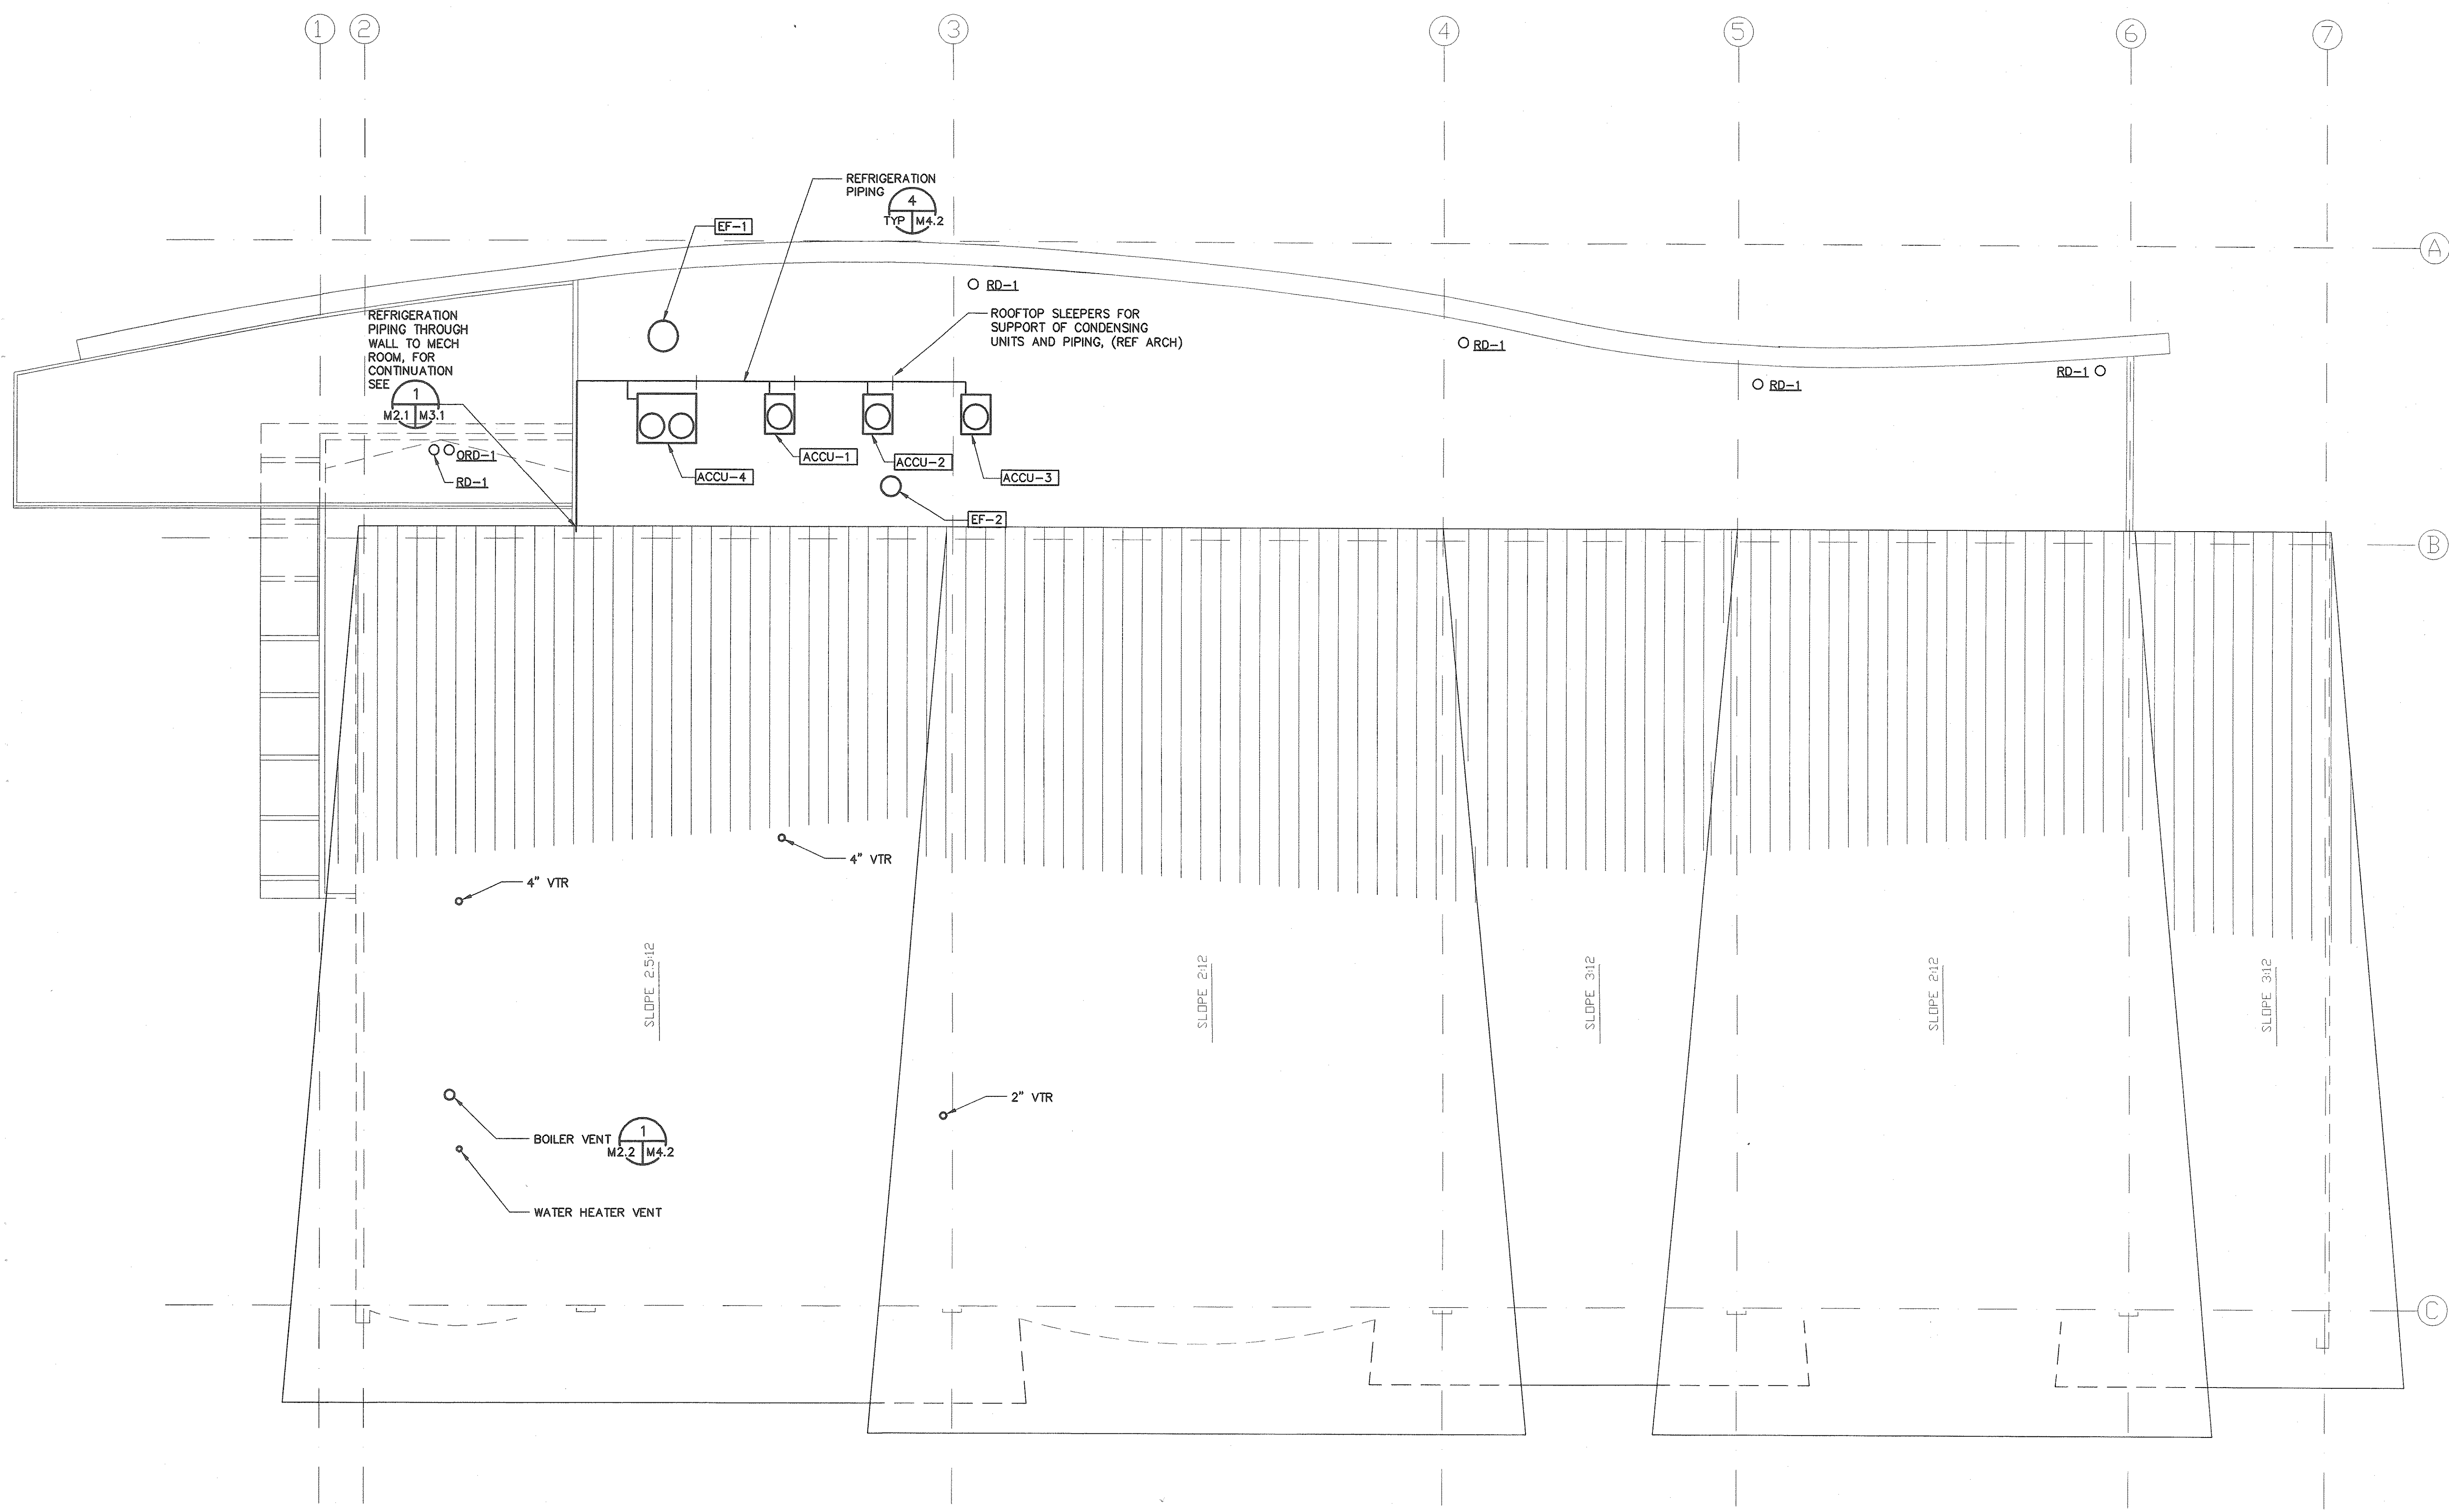

**MECHANICAL
ROOF PLAN**
SCALE: 1/8" = 1'-0"

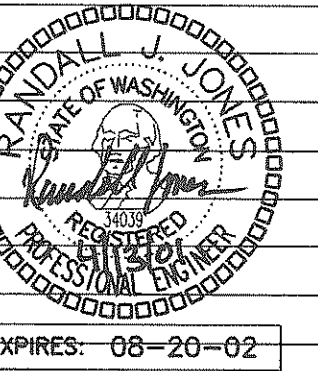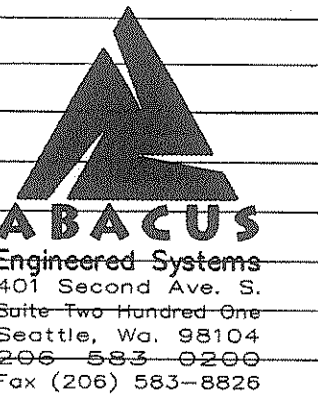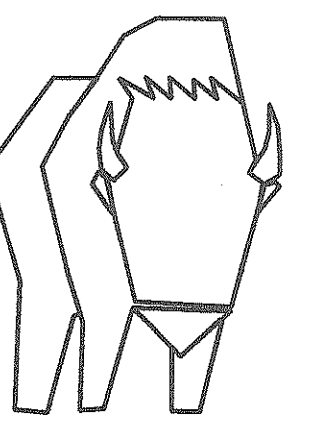

buffalodesign
architecture & interiors

1501 western
suite 500
seattle, wa
98101
206 467 6306
fax 206 624 1494

Sno-Isle
Regional Library System

monroe
library


village way,
monroe, washington 98272

BID
SET


project: 00-002
contents:
partial and enlarged plans

drawn: fem
checked: rj
date: 4/17/01
revised:


m3.1

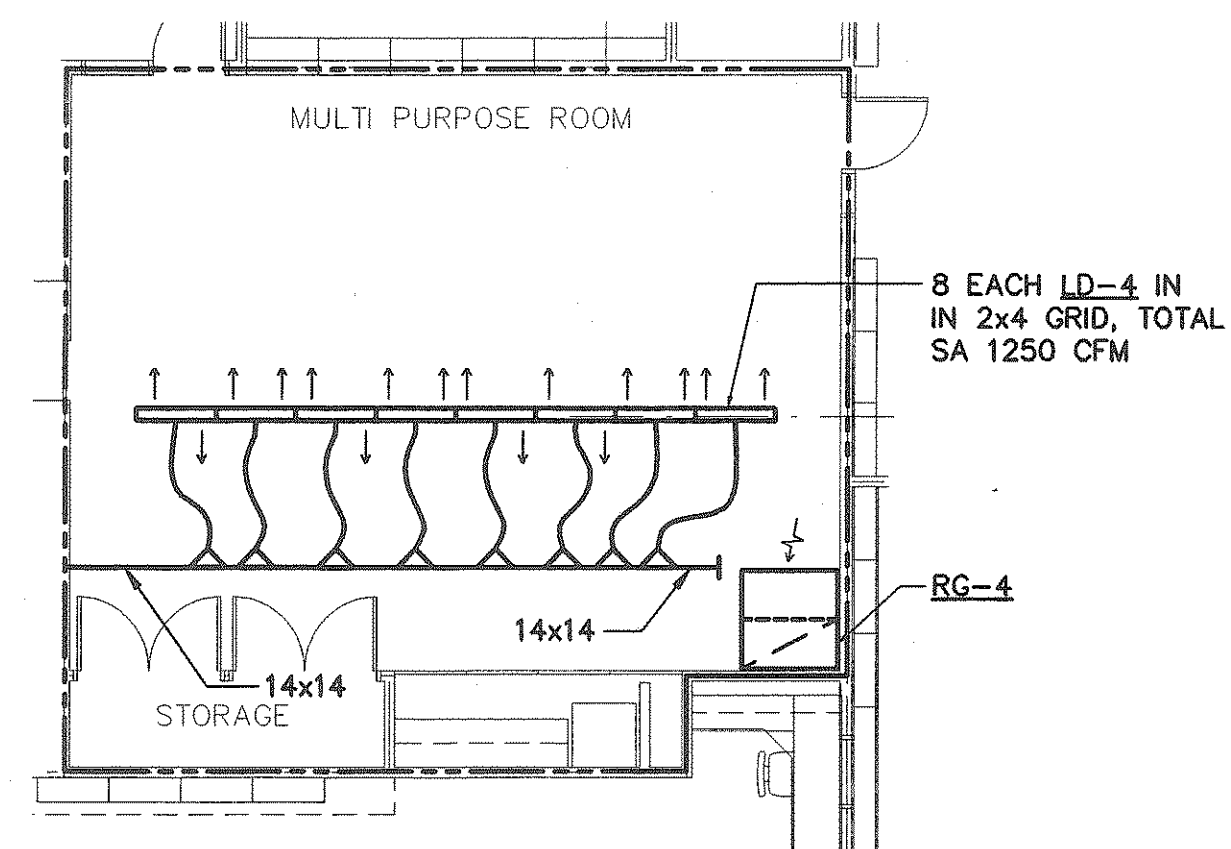


MULTI PURPOSE ROOM
HVAC PARTIAL PLAN (3)
SCALE: 1/8" = 1'-0"

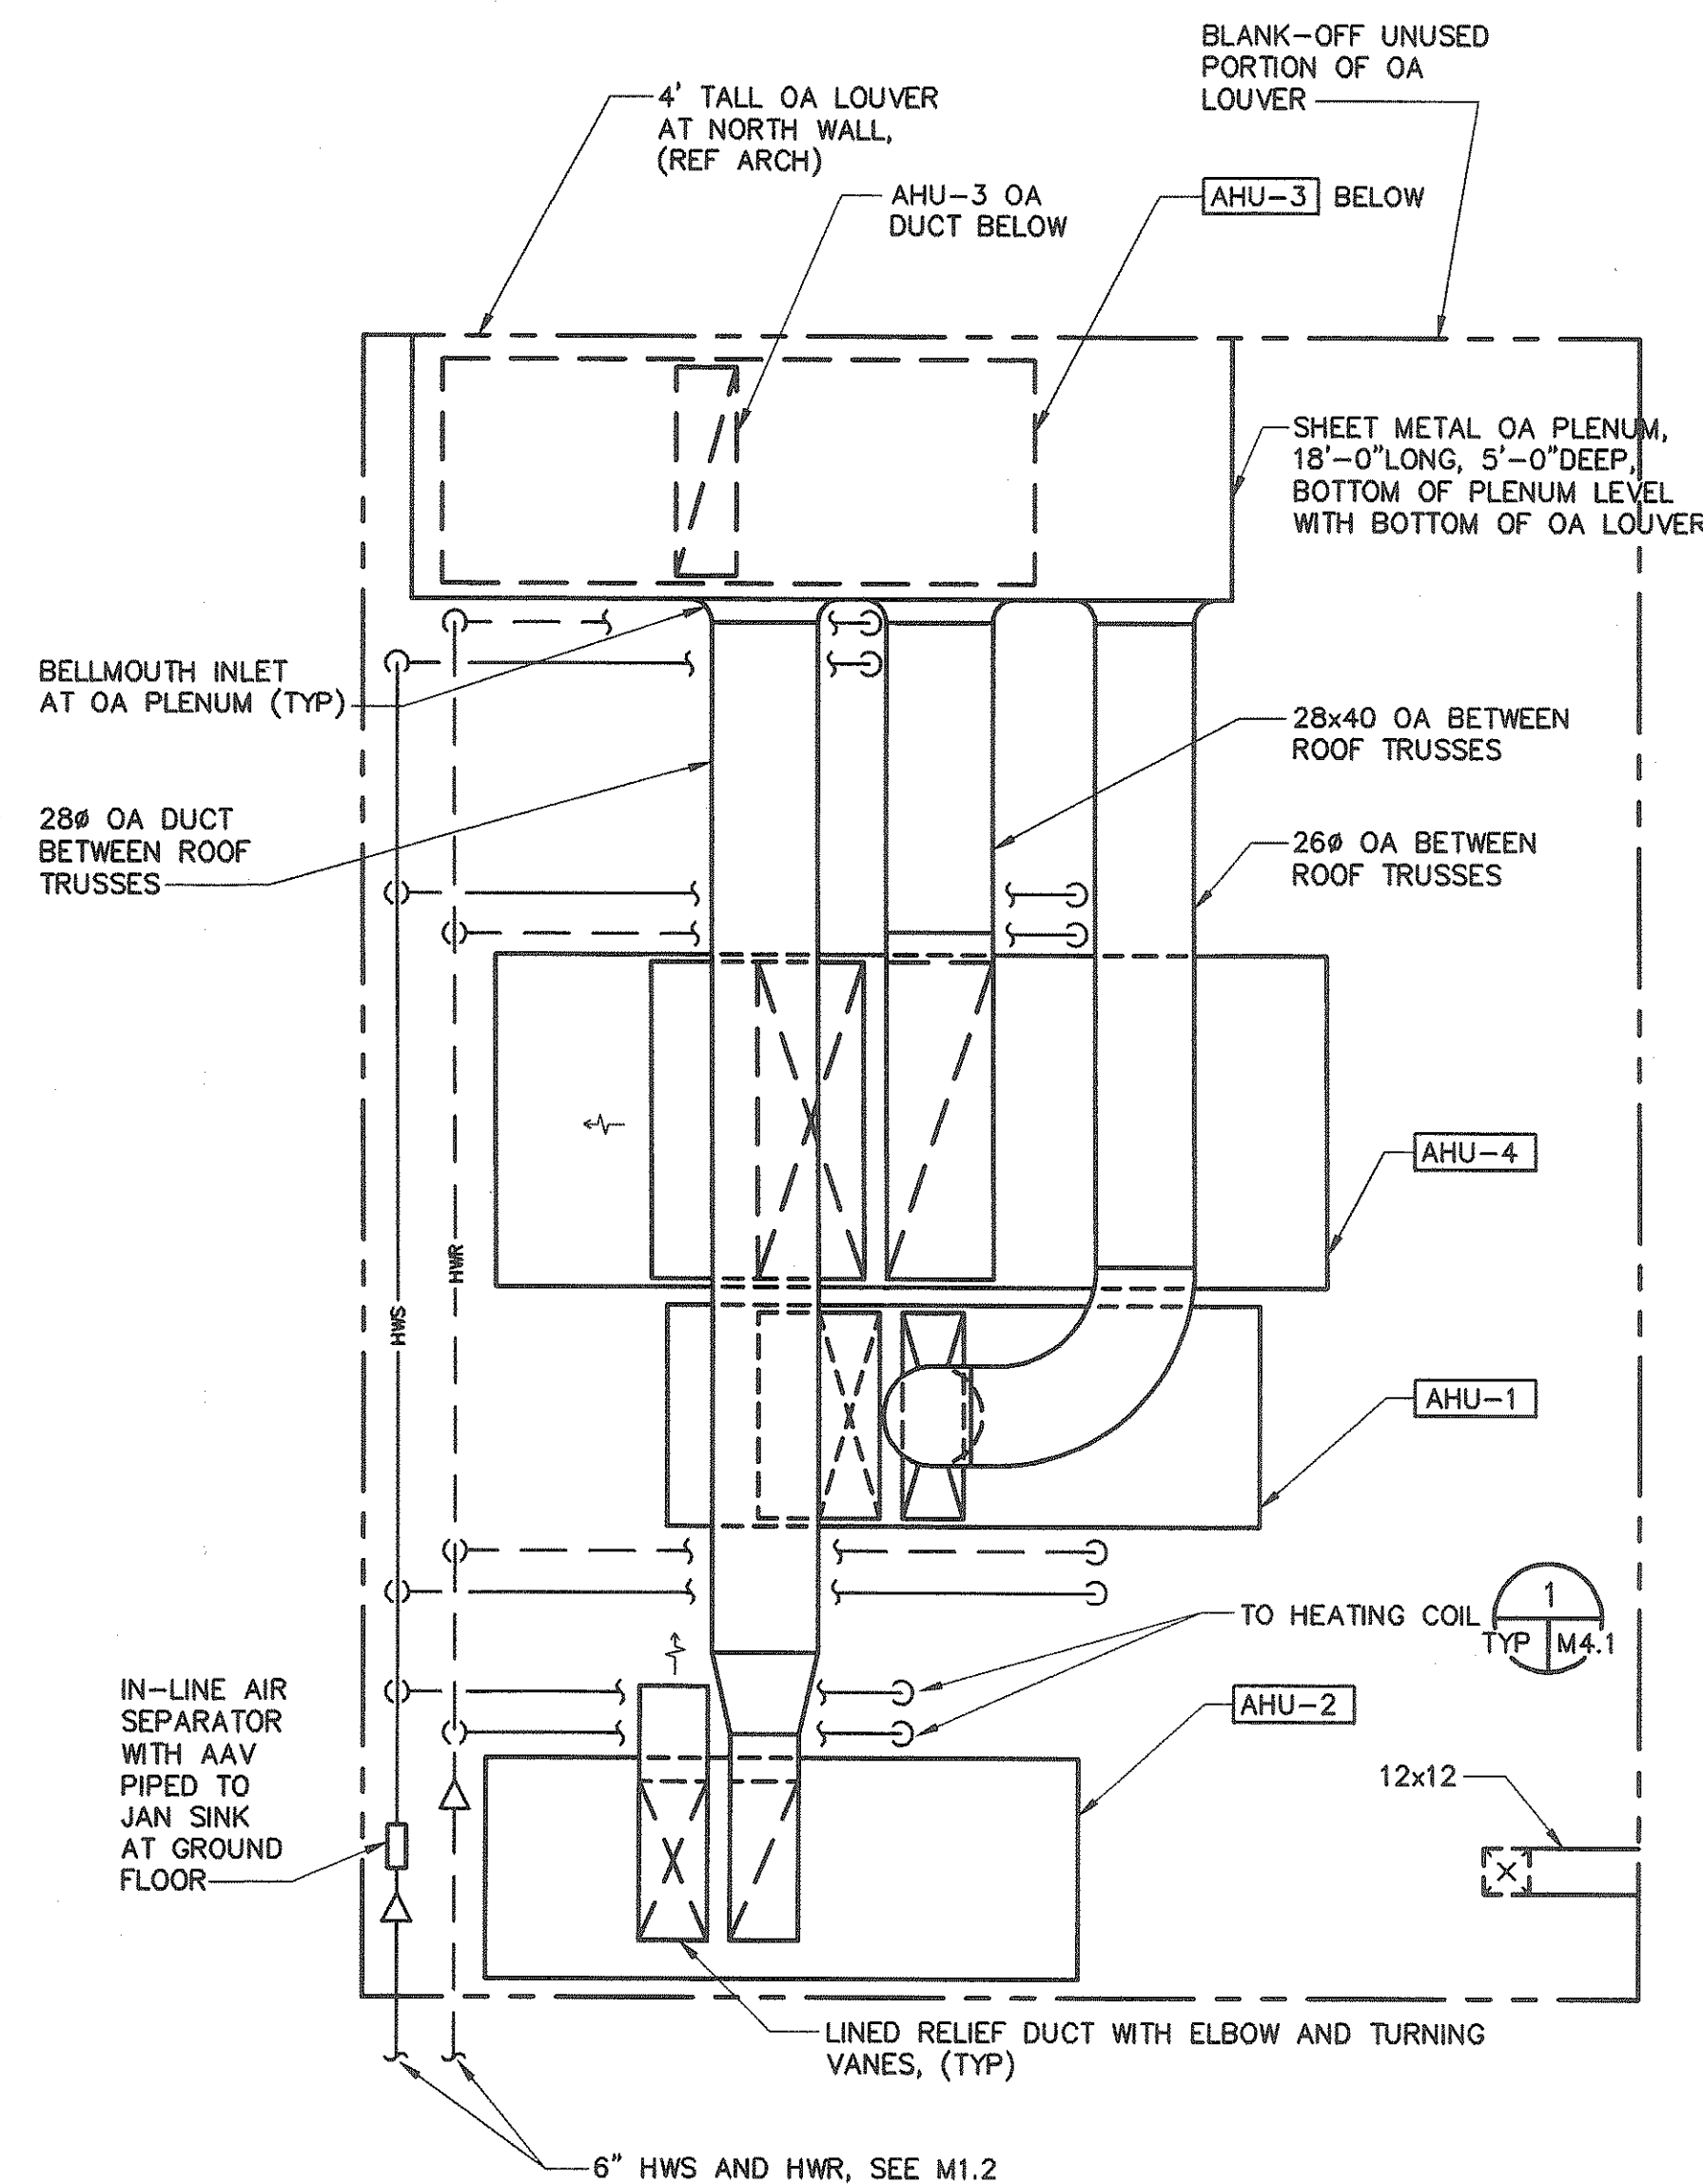

MEZZANINE MECHANICAL ROOM
UPPER LEVEL ENLARGED PLAN (2)
SCALE: 1/4" = 1'-0"

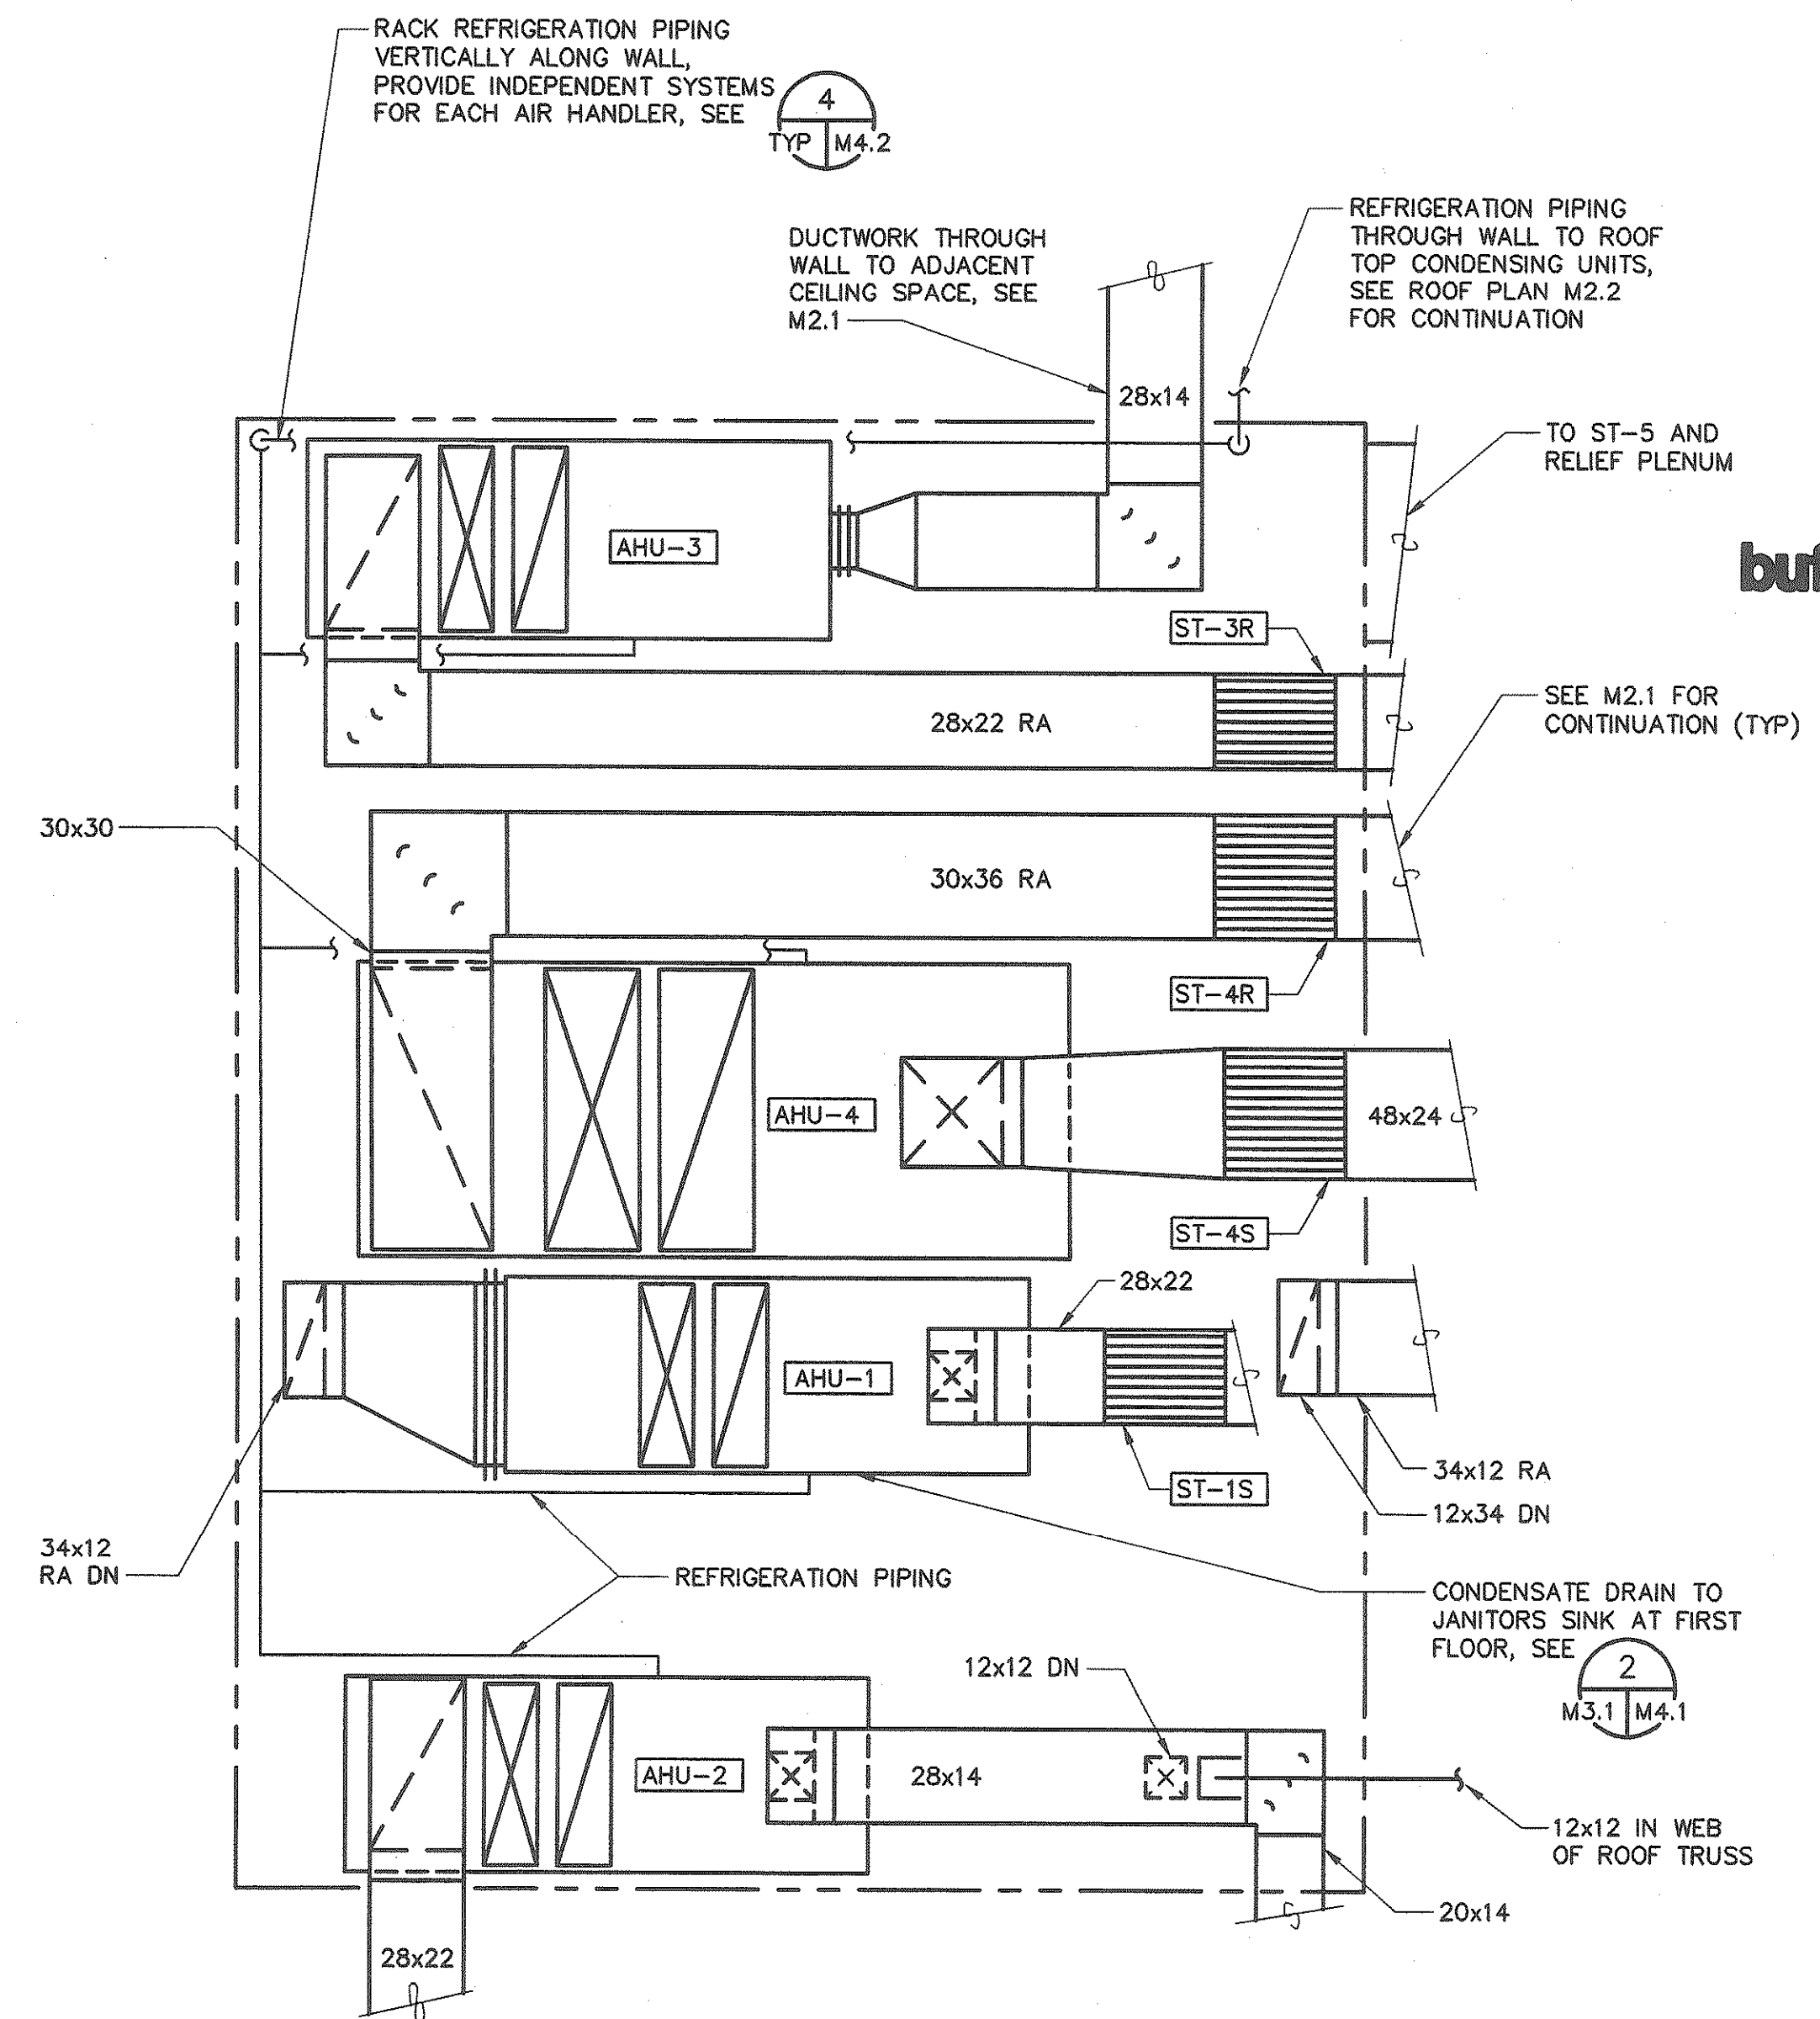

MEZZANINE MECHANICAL ROOM
LOWER LEVEL ENLARGED PLAN (1)
SCALE: 1/4" = 1'-0"

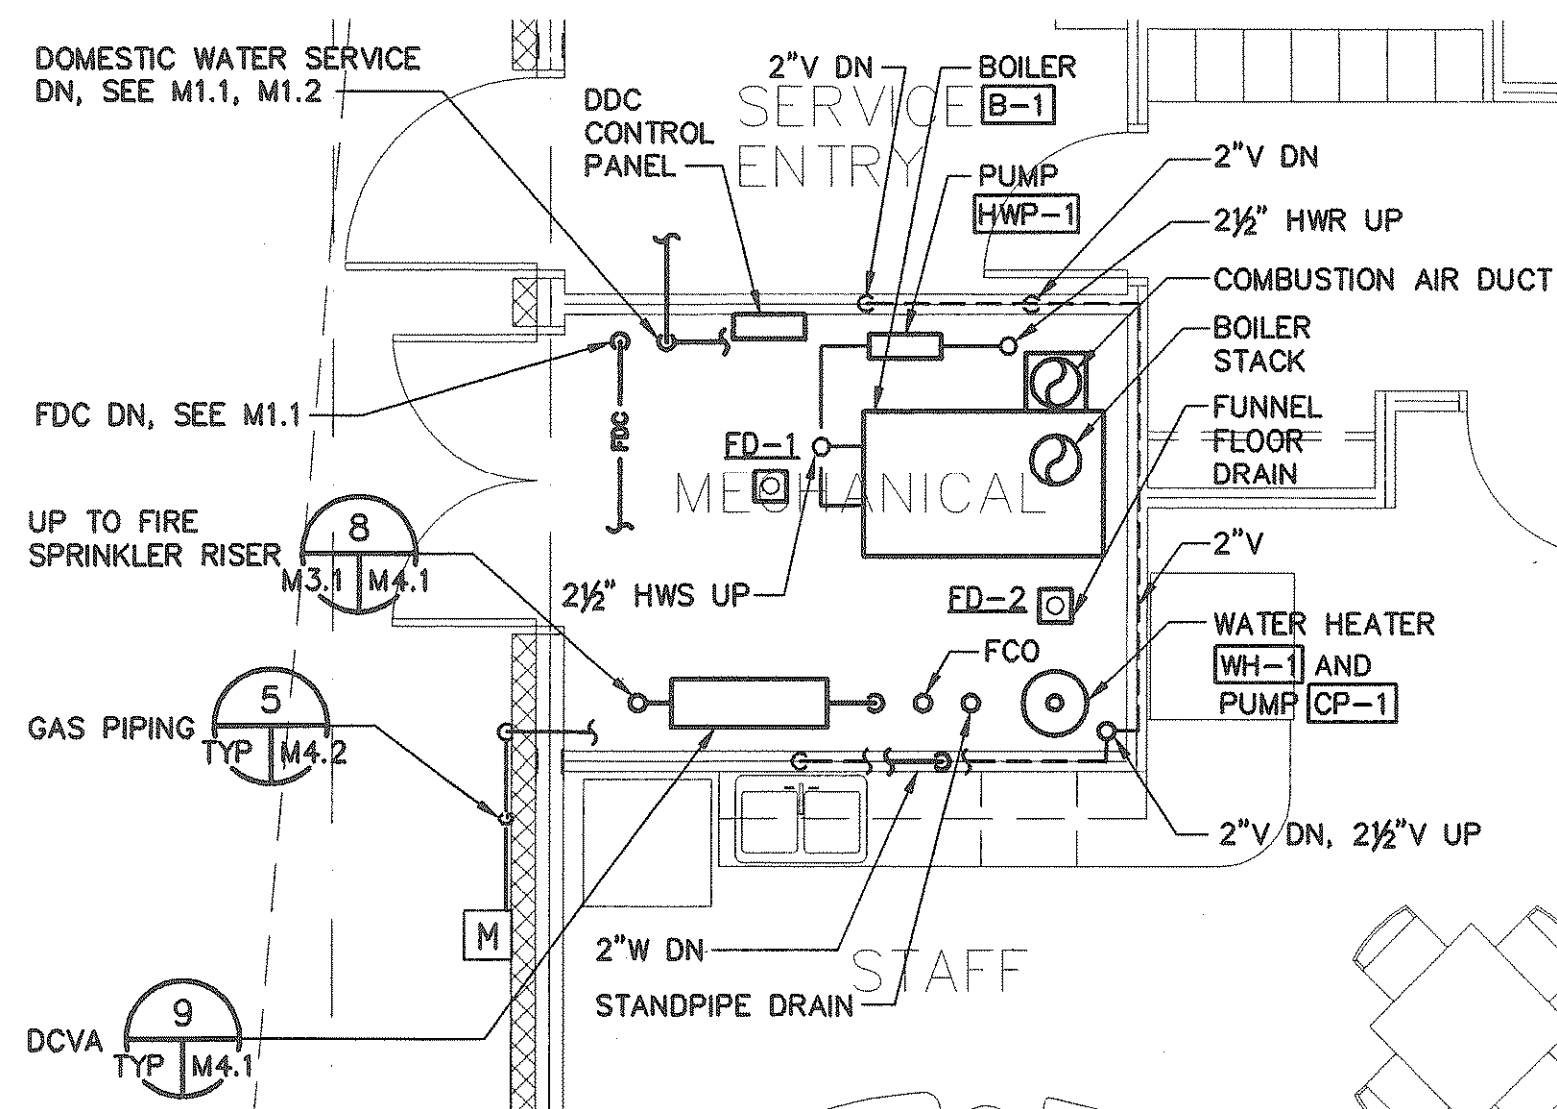

MECHANICAL ROOM
ENLARGED PLAN (4)
SCALE: 1/4" = 1'-0"